


## Got any questions?

<https://www.wwutilities.co.uk/services/gas-connections/connections-faq/>

### Alteration

- Cut off existing service that feeds the Café
- Connect off the existing 63mm PE LP Service
- Lay 27m public and 37m private
- Terminating to a Built In Meter Box
- \*\*Full Meter Reconnection up to 3m\*\*
- \*\*Fire Valve to be installed\*\*

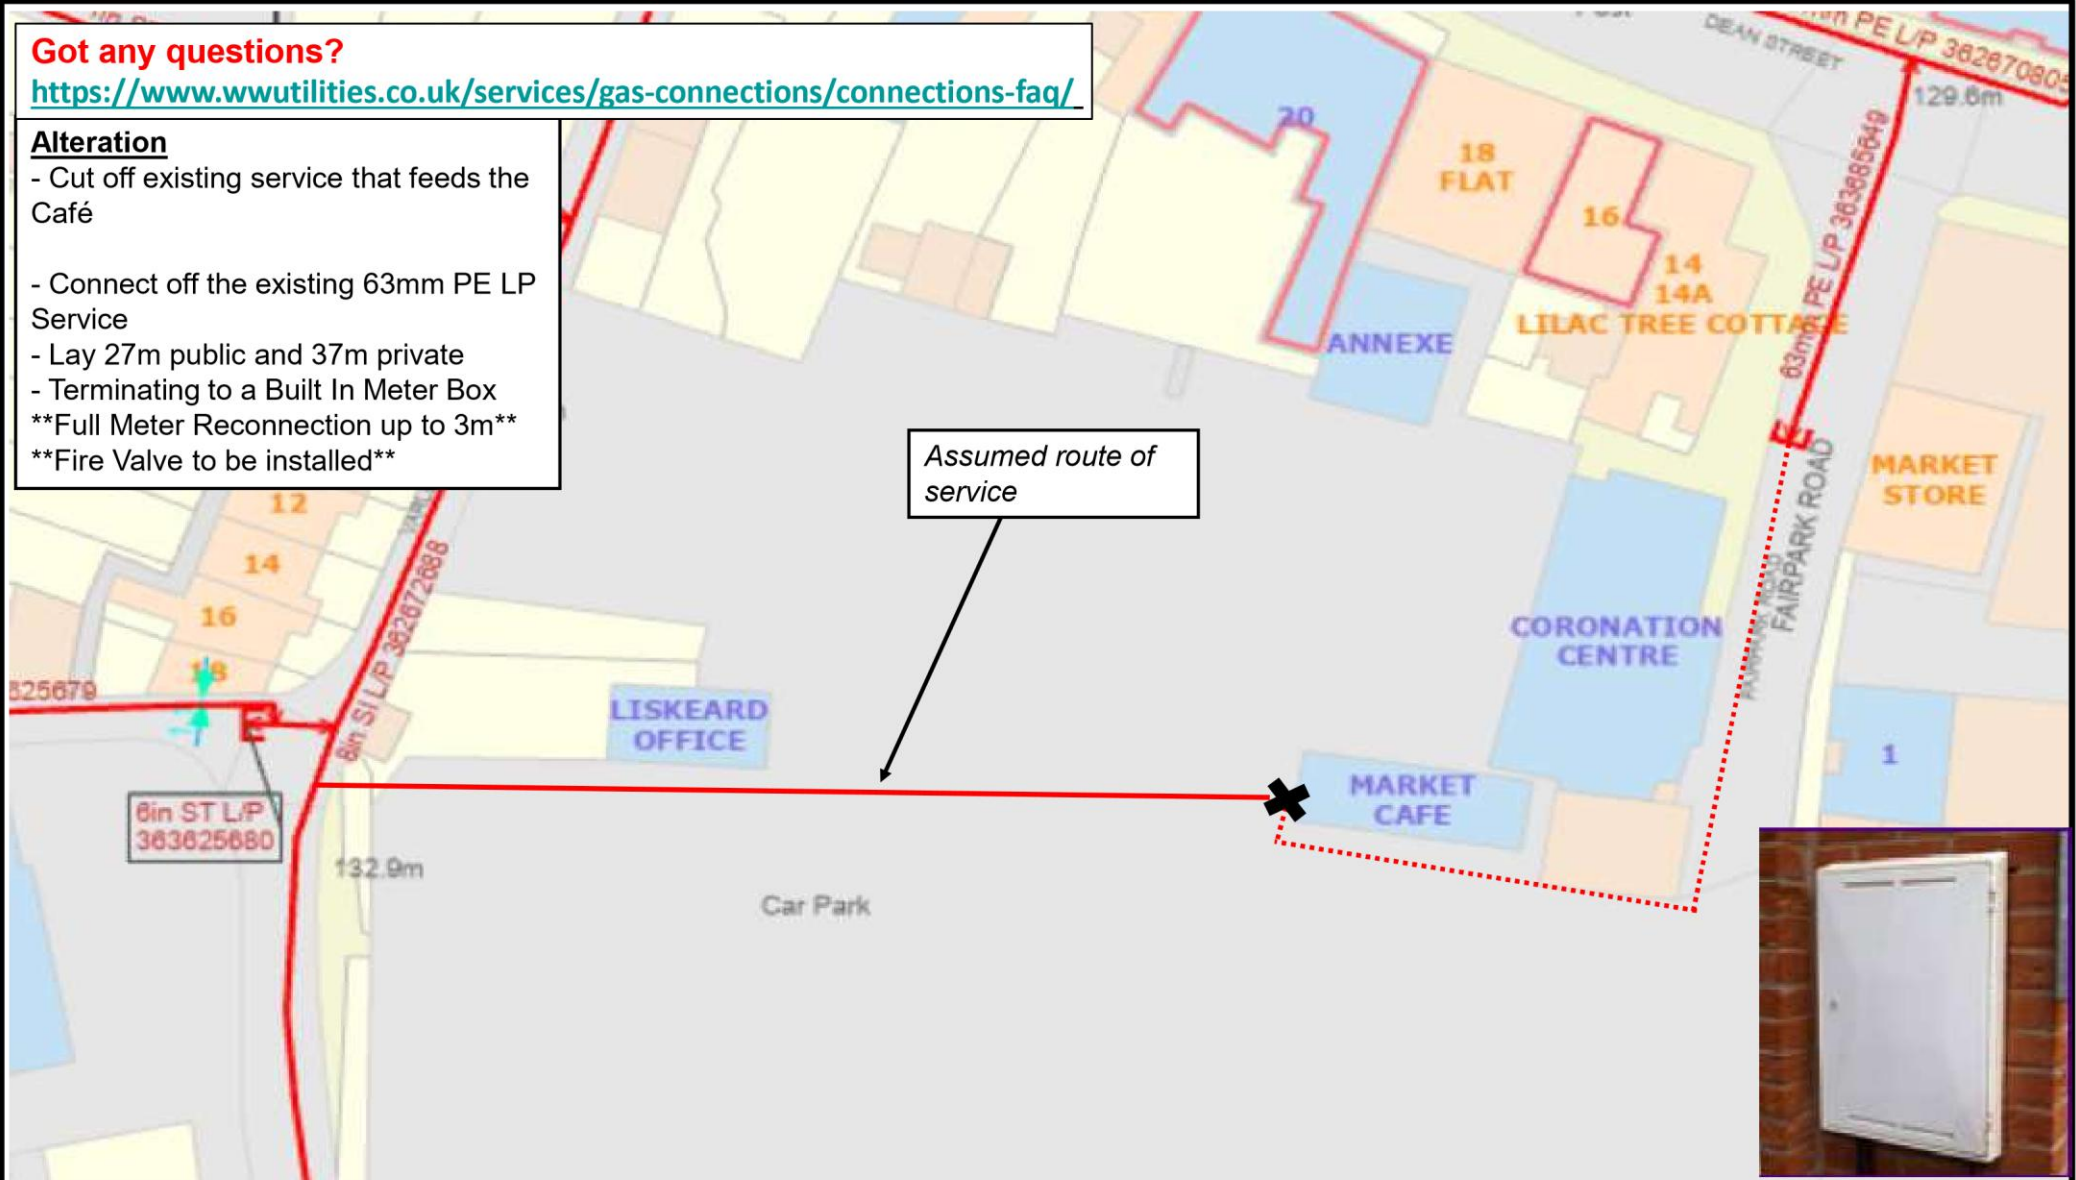

Reproduced by permission of Ordnance Survey on behalf of HMSO.  
© Crown Copyright and database right 2018. All rights reserved.  
Ordnance Survey Licence number 0100044308.

- Low Pressure (LP) 21mbar – 75mbar
- - - Medium Pressure (MP) 350mbar – 2bar
- - - Intermediate Pressure (IP) 2bar – 7bar
- - - High Pressure (HP) >7bar
- Line/Fire Valve
- Governor Station
- Change of Diameter
- End Cap

Document Version: CONN\_LF\_WW\_233

35070347 - Market Café, Dean Street, Liskeard PL14 4AA

<b>Date:</b>	25.09.2024
<b>Designer:</b>	Sarah Blackborow
<b>Telephone Number:</b>	
<b>Drawing Number:</b>	One of One
<b>Grid Reference:</b>	225013 64441

The plan shows those pipes owned by Wales & West Utilities or the relevant Gas Distribution Network in their roles as Licenced Gas Transporters (GT). Gas Pipes owned by other GTs, or otherwise privately owned, may be present in this area. Information with regard to such pipes should be obtained from the relevant owners. The information shown on this plan is given without warranty, the accuracy thereof cannot be guaranteed. Service pipes, valves, syphons, stub connections, etc. are not shown but their presence should be anticipated. No liability of any kind whatsoever is accepted by Wales & West Utilities, the relevant Gas Distribution Network, or their agents, servants or contractors for any error or omission. Safe digging practices, in accordance with HS(G)47, must be used to verify and establish the actual position of mains, pipes, services and other apparatus on site and before any mechanical plant is used. It is your responsibility to ensure that this information is provided to all persons (either direct labour or contractors) working for you or near gas apparatus. The information included on this plan should not be referred to beyond a period of 28 days from the date of issue.

**Smell gas?**  
Call the Gas Emergency Service on 0800 111 999.

**Dial before you dig**

**Dial**  
Call 029 2027 8912 before you start work.

**Investigate**  
Before you dig, make sure you know what's below.

**Go ahead**  
Done your research? Now you can dig safely.

We need 10 days' notice